


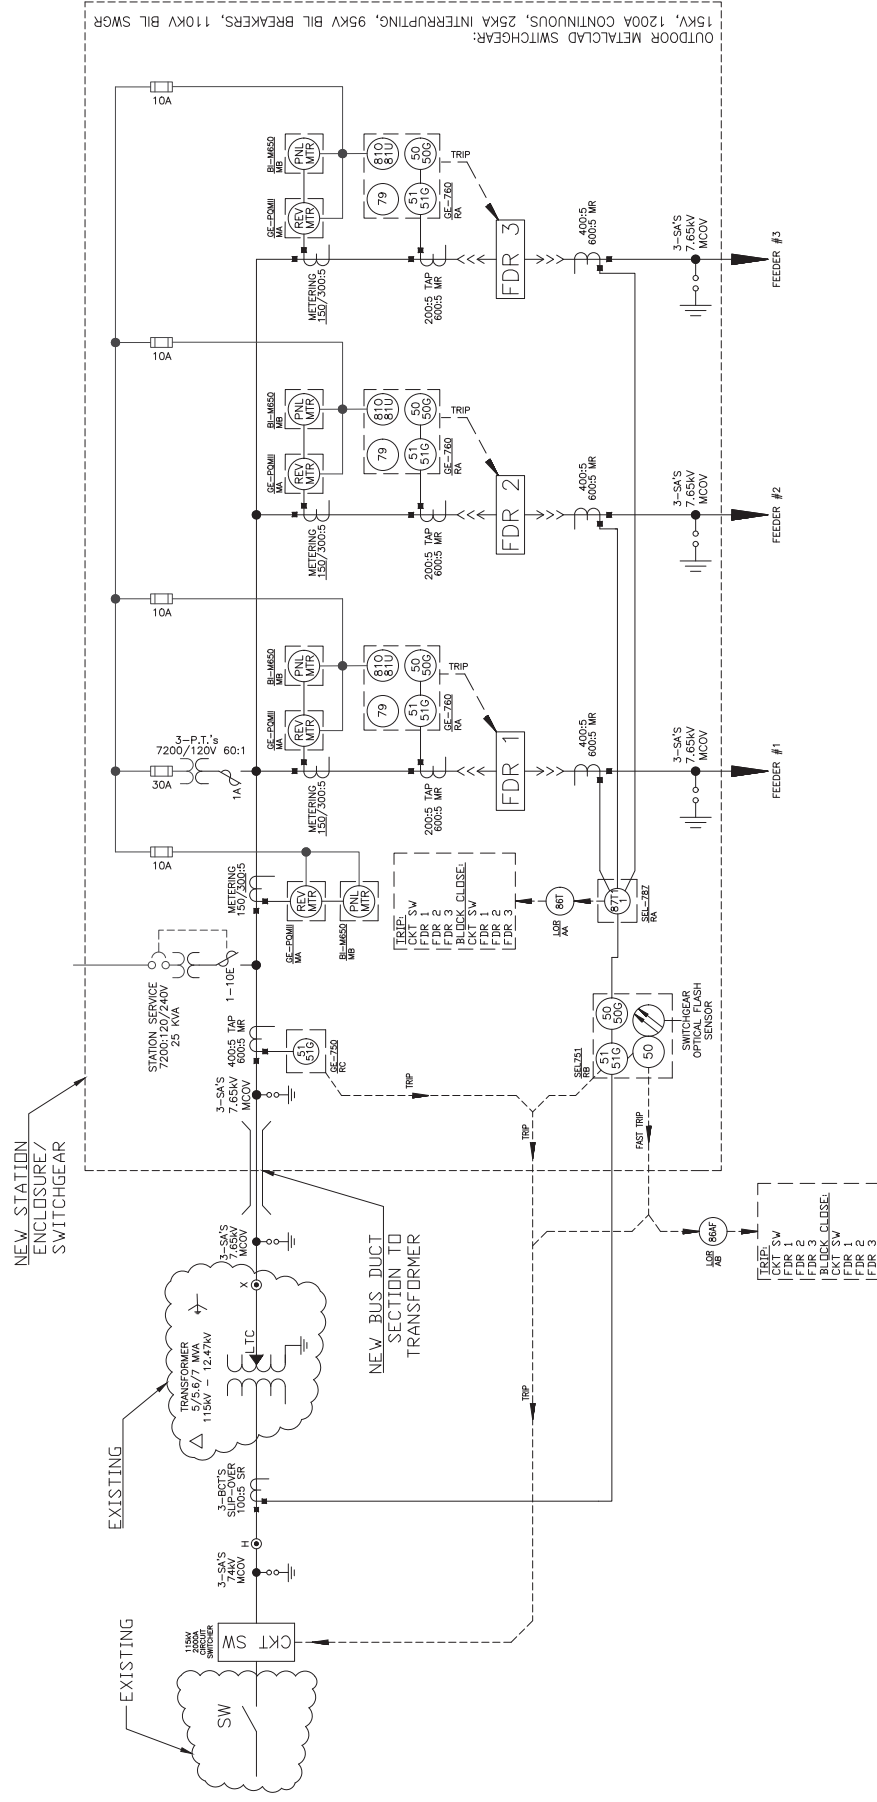

LEGEND	
	POWER TRANSFORMER
	DISCONNECT SWITCH
	BACK OUT CIRCUIT BREAKER
	DRAW-OUT PRIMARY FUSE
	SURGE ARRESTER
	CURRENT TRANSFORMER
	POTENTIAL TRANSFORMER
	SECONDARY FUSE
	FIBER OPTIC
	PHASE (L1) AND RESIDUAL GROUND (51G) TIME OVERCURRENT PROTECTION
	LOCK-OUT RELAY
	PHASE (50) AND RESIDUAL GROUND (50G) INSTANTANEOUS OVERCURRENT PROTECTION
	RECLOSE
	TRANSFORMER DIFFERENTIAL PROTECTION
	UNDER FREQUENCY PROTECTION
	UNDER RESIDUAL PROTECTION
	GE-PQM1 REVENUE / POWER QUALITY METER
	BIONICS M550 PANEL METER

 This drawing is a copyrighted work product of T & D Services, LLC. Any reproduction, copying, or use of this drawing, in whole or in part, without the written consent of T & D Services, LLC is strictly prohibited.	Transmission & Distribution Services Consulting Engineers & Surveyors 4000 West 10th Street, Suite 100 Albuquerque, NM 87131 505.263.8888 www.tdservices.com		LOS ALAMOS COUNTY DEPARTMENT OF PUBLIC UTILITIES LOS ALAMOS, NM		DATE 	REVISIONS 	WHITE ROCK SUBSTATION PROPOSED ONE-LINE DIAGRAM	
	DRAWN: JAC	CHK: KWA	APP'D: GRN	DATE: JANUARY 2018	JOB #:	SCALE	STATE	SHEET
						NONE	NM	WR-201A